

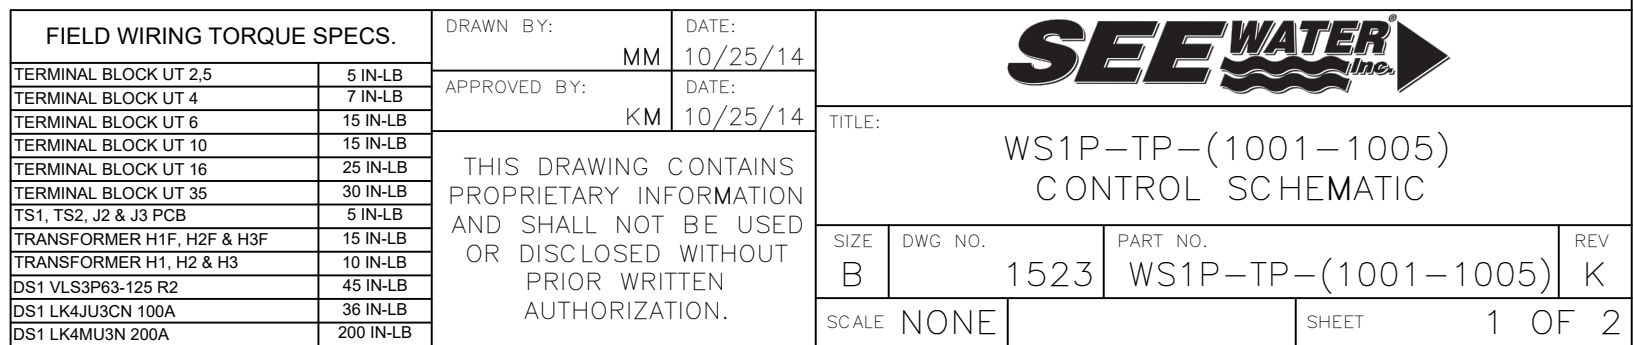


REVDATE: 0521

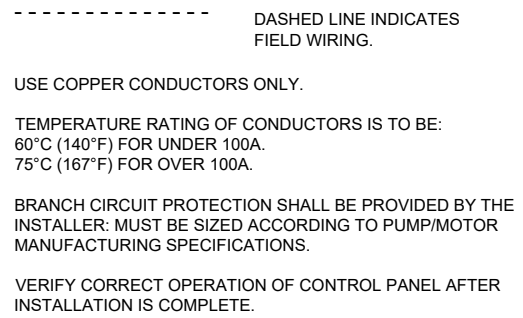

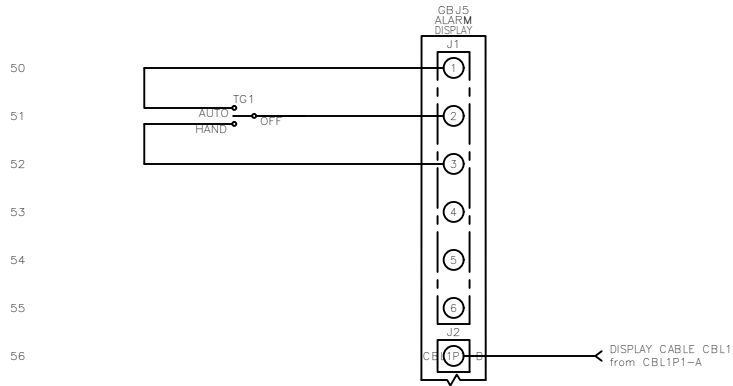

75

76

77

78

79

80

81

82

83

84

85

86

87

88

89

90

91

92

93

94

95

96

97

98

99

----- DASHED LINE INDICATES
FIELD WIRING.

USE COPPER CONDUCTORS ONLY.

TEMPERATURE RATING OF CONDUCTORS IS TO BE:
60°C (140°F) FOR UNDER 100A.
75°C (167°F) FOR OVER 100A.

BRANCH CIRCUIT PROTECTION SHALL BE PROVIDED BY THE
INSTALLER: MUST BE SIZED ACCORDING TO PUMP/MOTOR
MANUFACTURING SPECIFICATIONS.

VERIFY CORRECT OPERATION OF CONTROL PANEL AFTER
INSTALLATION IS COMPLETE.

FIELD WIRING TORQUE SPECS.		DRAWN BY: MM	DATE: 10/25/14				
TERMINAL BLOCK UT 2,5	5 IN-LB	APPROVED BY: KM	DATE: 10/25/14				
TERMINAL BLOCK UT 4	7 IN-LB	THIS DRAWING CONTAINS PROPRIETARY INFORMATION AND SHALL NOT BE USED OR DISCLOSED WITHOUT PRIOR WRITTEN AUTHORIZATION.		TITLE: WS1P-TP-(1001-1005) CONTROL SCHEMATIC			
TERMINAL BLOCK UT 6	15 IN-LB			SIZE B	DWG NO. 1523	PART NO. WS1P-TP-(1001-1005)	REV K
TERMINAL BLOCK UT 10	15 IN-LB			SCALE NONE		SHEET 2 OF 2	
TERMINAL BLOCK UT 16	25 IN-LB						
TERMINAL BLOCK UT 35	30 IN-LB						
TS1, TS2, J2 & J3 PCB	5 IN-LB						
TRANSFORMER H1F, H2F & H3F	15 IN-LB						
TRANSFORMER H1, H2 & H3	10 IN-LB						
DS1 VLS3P63-125 R2	45 IN-LB						
DS1 LK4JU3CN 100A	36 IN-LB						
DS1 LK4MU3N 200A	200 IN-LB						

